


**Garden Grove
Police
Department**

11301 Acacia Pkwy.
Garden Grove, CA.
92840

**Interior Tenant
Improvement for
Records
Department**

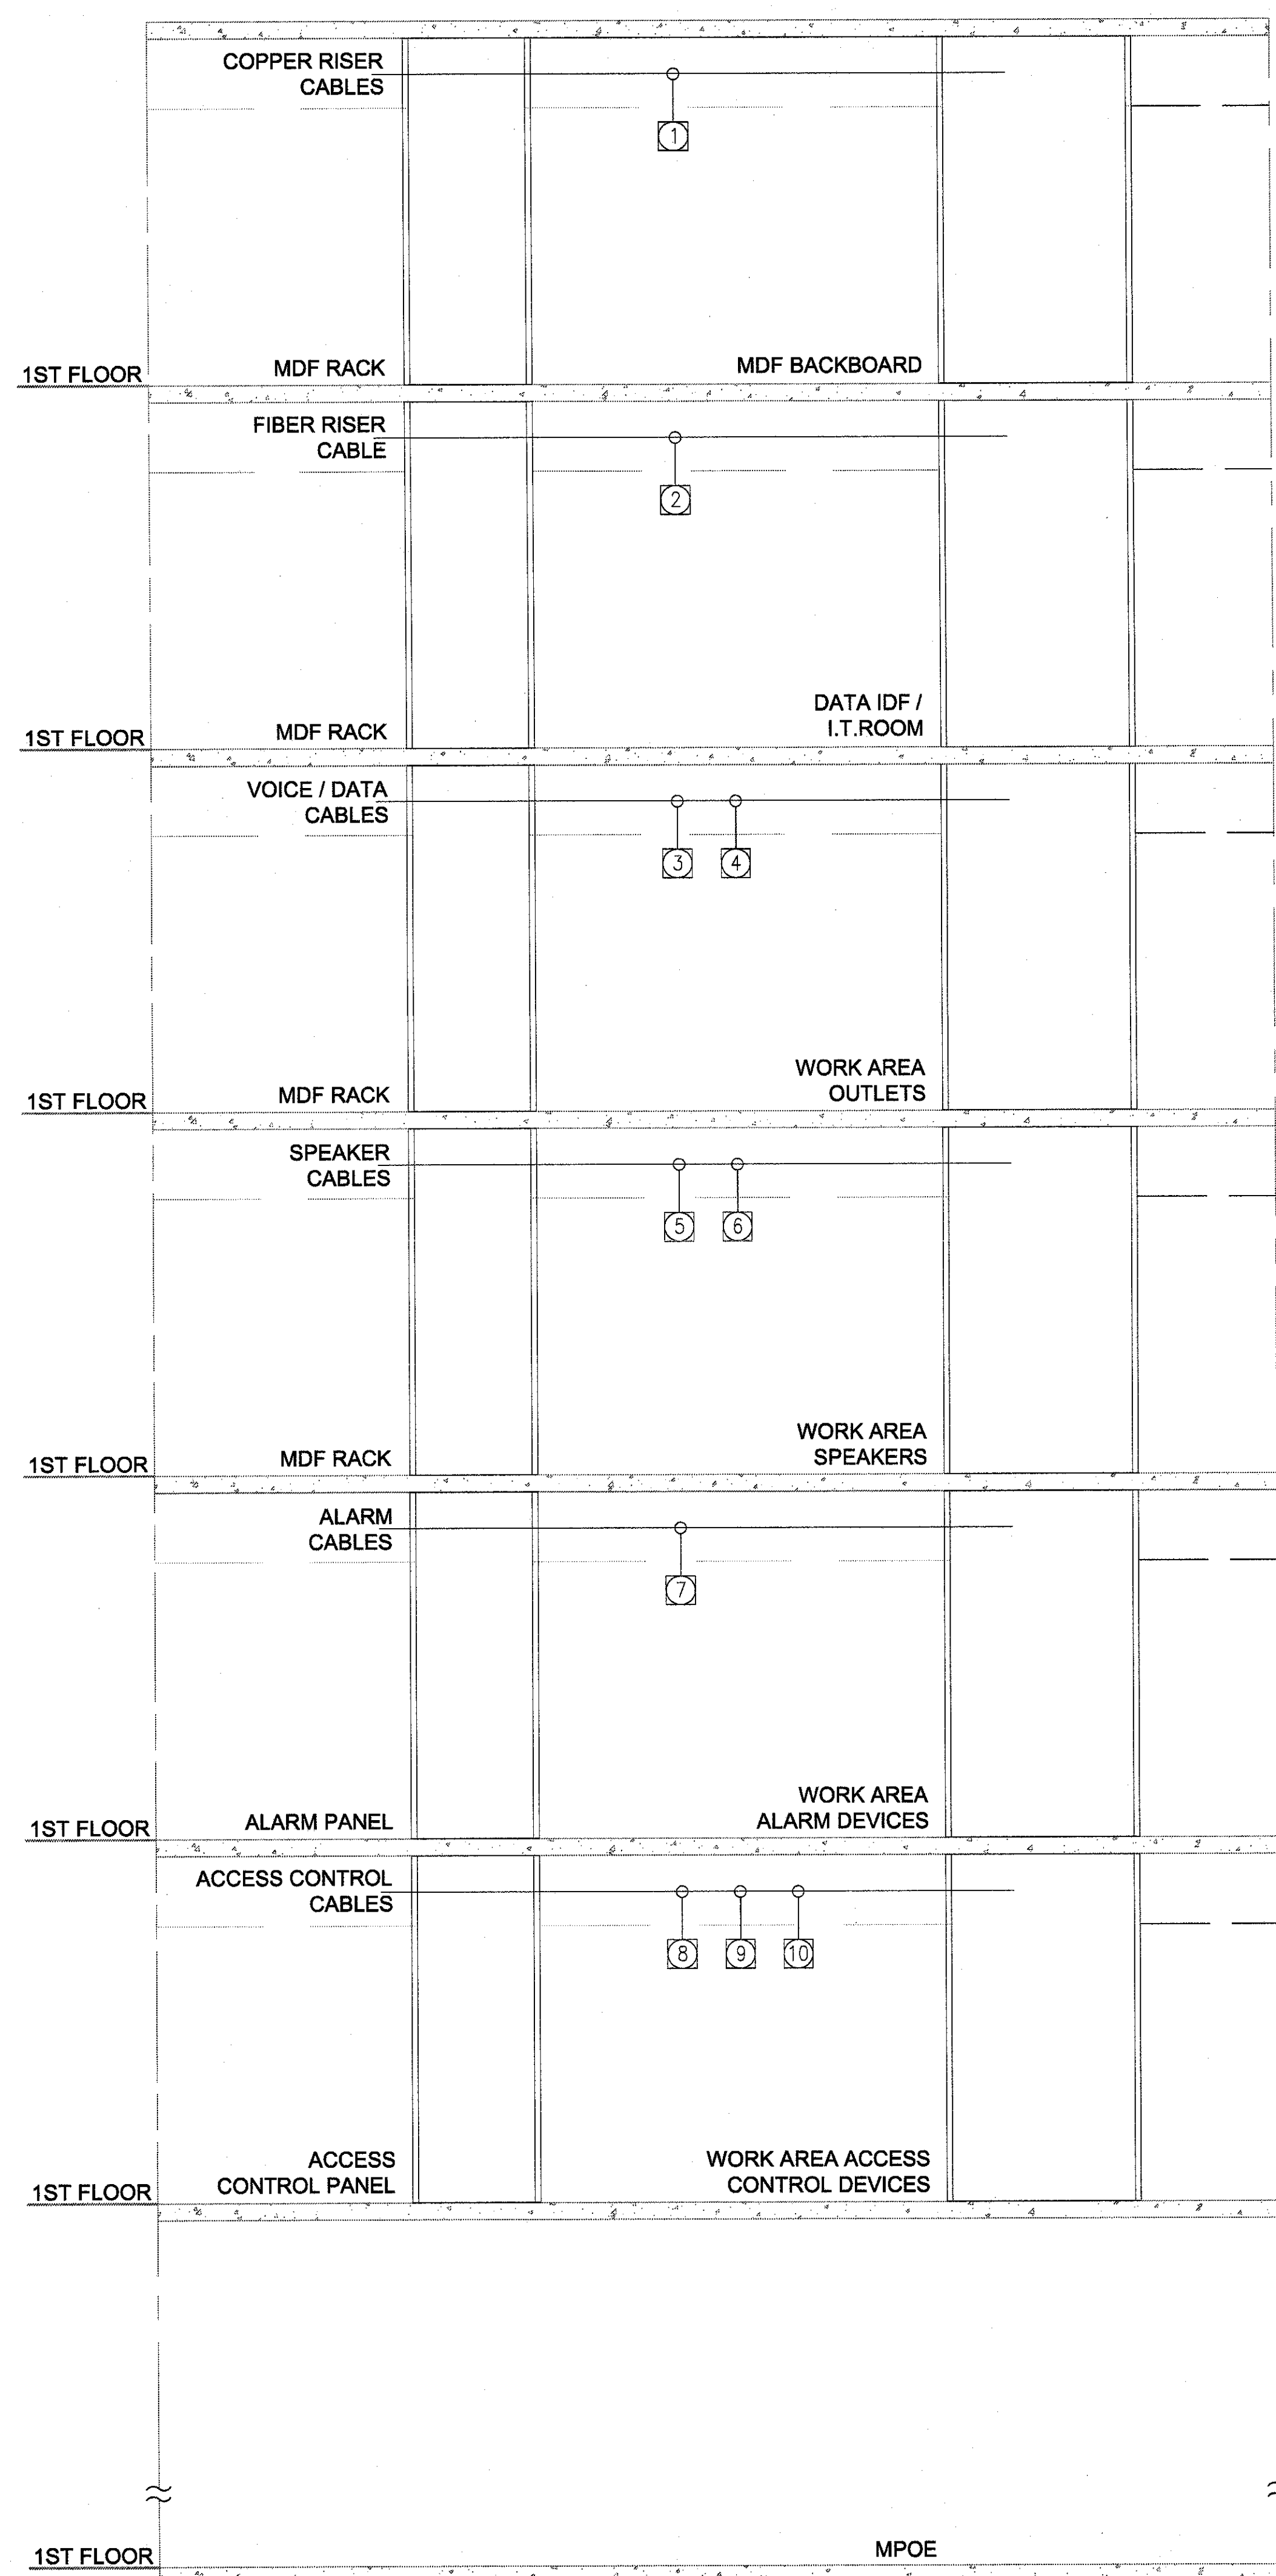

KEY NOTES

- 1 2 x 50-PAIR CATEGORY 3 COPPER CABLES FROM NEW MDF EQUIPMENT RACK TO MDF BACKBOARD FOR CENTREX LINES [BELDEN P/N DPLN50]
- 2 1 X 12-STRAND OM3 ARMORED FIBER OPTIC CABLE FROM NEW MDF EQUIPMENT RACK TO EXISTING DATA IDF / I.T. ROOM [CORNING P/N 012E88-33131-A3]
- 3 CATEGORY 6 WORK STATION CABLES FOR VOICE * BELDEN 2400 SERIES PLENUM - WHITE, QTY AS INDICATED ON FLOOR PLAN [BELDEN P/N 2413 0091000]
- 4 CATEGORY 6 WORK STATION CABLES FOR DATA * BELDEN 2400 SERIES PLENUM - BLUE, QTY AS INDICATED ON FLOOR PLAN [BELDEN P/N 2413 D15U100]
- 5 (1) 18-2 PLENUM RATED SPEAKER WIRE FOR ZONE 1 [BELDEN P/N 6300FC]
- 6 (2) 18-2 PLENUM RATED SPEAKER WIRE FOR ZONE 2 [BELDEN P/N 6300FC]
- 7 (5) 22/4 PLENUM RATED CABLES FOR PANIC BUTTONS [BELDEN P/N 6502UE]
- 8 (8) 18/2 PLENUM RATED CABLES FOR DOOR RELEASE BUTTONS [BELDEN P/N 6320UE]
- 9 (1) 18/4 PLENUM RATED CABLE FOR CARD READER POWER [BELDEN P/N 6302UE]
- 10 (1) 22/6 PLENUM RATED CABLE FOR CARD READER CONTROL / DATA [BELDEN P/N 6504FE]

* NOTE: FOR CATEGORY 6A OPTION USE THE FOLLOWING BELDEN SERIES 10GXS13 PART NUMBERS:


CATEGORY 6A WORK STATION CABLES FOR VOICE - PLENUM, WHITE [BELDEN P/N 10GXS13 0091000]

CATEGORY 6A WORK STATION CABLES FOR DATA - PLENUM, BLUE [BELDEN P/N 10GXS13 D151000]

1 SINGLE LINE DIAGRAM
SCALE: N.T.S.



Issue	Description	Date
1	PCC - PRELIMINARY	02/01/2017

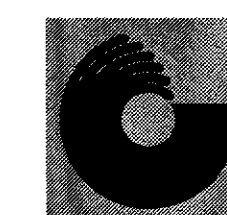

PCC Network Solutions
Design. Build. Deliver.

PCC Network Solutions
20717 Prairie St
Chatsworth, CA 91311
t: 818.407.1911
f: 818.407.1913

Telecommunication Contractor

Drawn: PCC Check: PCC Owner Approval:

Job No: - Scale: 1/4" = 1'-0"